
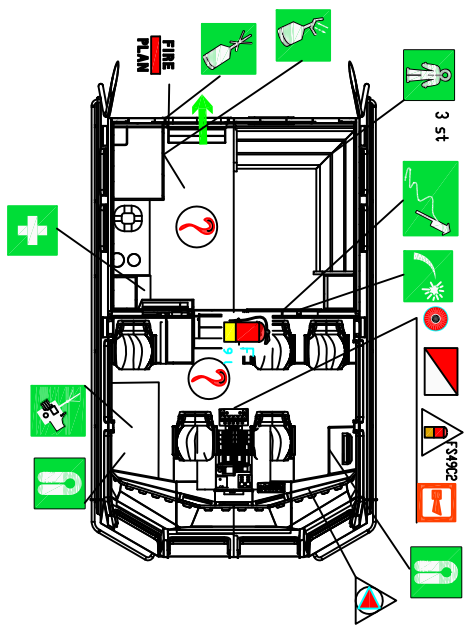
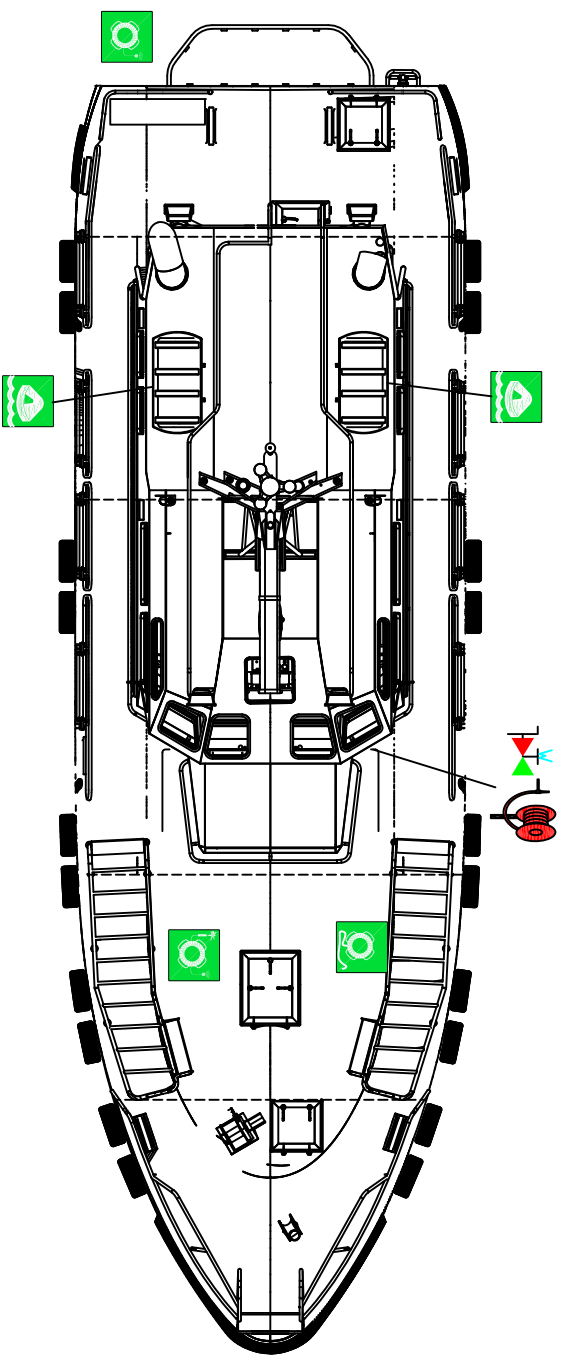
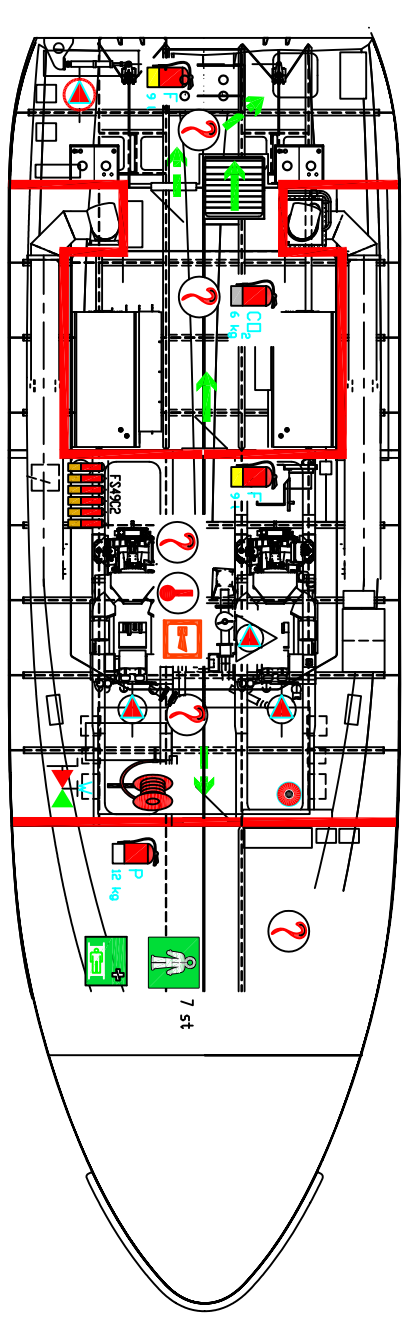


	MANUELL EP1R8	MANUELL EP1R8	1		BRANNARSENTRAL	CONTROL PANEL FOR FIRE DETECTION AND ALARM SYSTEM	1
	BRANNALARM	FIRE ALARM	3		BRANNISLERING KLASSE A	A-CLASS DIVISION	1
	BRANNP1ST	FIRE HYDRANT	2		MANUELL UTJÄSER FÖR BRANNALARM	PUSH BUTTON FOR GENERAL ALARM	2

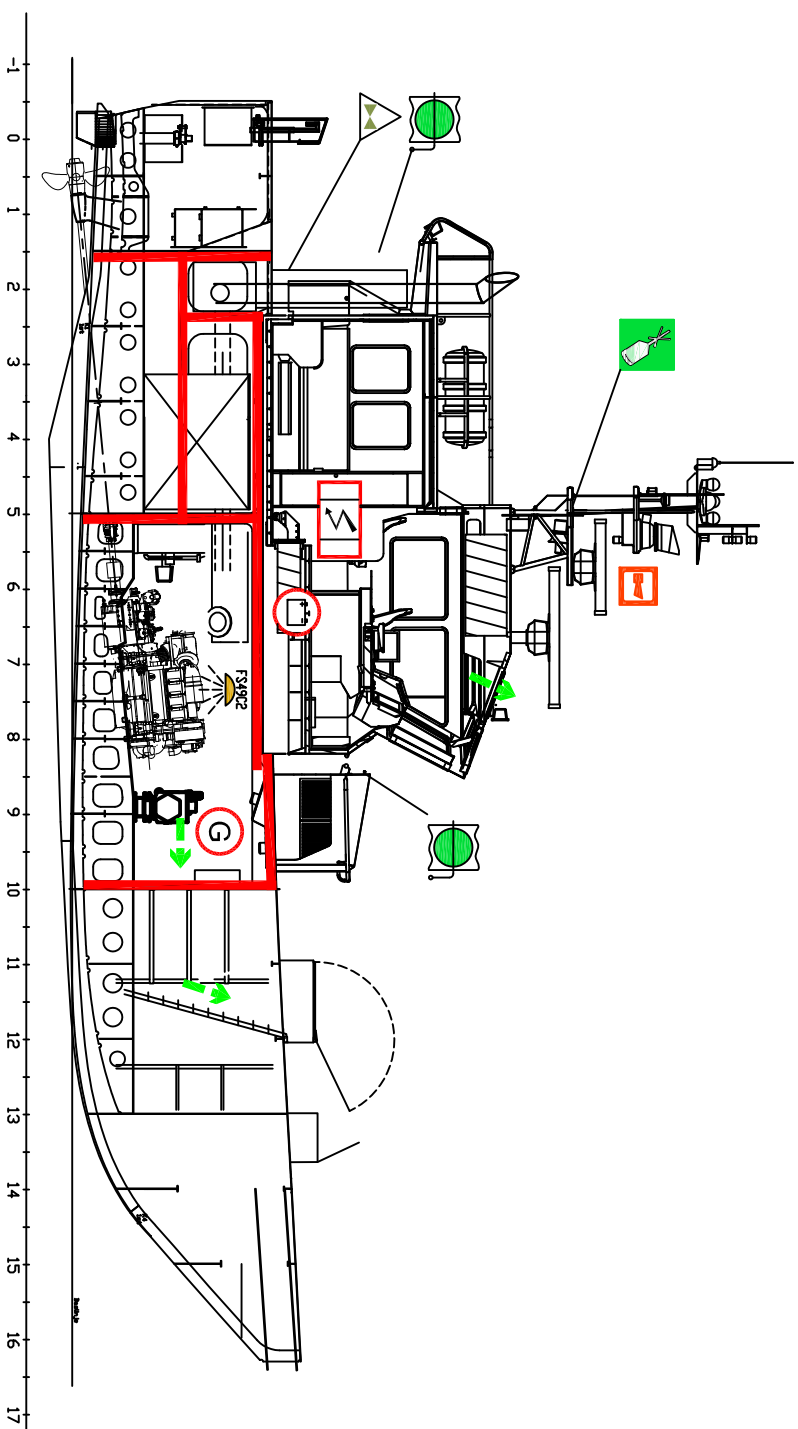

	BRANNARSENTRAL	CONTROL PANEL FOR FIRE DETECTION AND ALARM SYSTEM	1
	BRANNISLERING KLASSE A	A-CLASS DIVISION	1
	MANUELL UTJÄSER FÖR BRANNALARM	PUSH BUTTON FOR GENERAL ALARM	2
	RYÖKTEKTUR	SPACE MONITORED BY SMOKE DETECTOR	7
	VÄRMEDETEKTOR	SPACE MONITORED BY	1
	BRANNFÄLD MASKINOM	FIRE DAMPER, MACHINERY SPACE	2
	BRANN- OG SIKKERHETSPLAN	FIRE PROTECTION PLAN	1
	BRANNPUMPE 7-15 m ³ /h ved 3 bar	FIRE PUMP 7-15 m ³ /h at 3 bar	2
	TRANSPORTABEL BRANN-LENSEPUMPE	EMERGENCY FIRE PUMP	1
	START AV BRANNPUMPE	REMOTE CONTROL FOR FIRE PUMP	2
	FJERNSTYRING AV RØD VENTILER	REMOTE CONTROL FOR FUEL OIL VALVE	1
	UTJÄSER FÖR SLUKKEANLEGG HANSON	REMOTE RELEASE STATION, gas	1
	BRANNSLANGE M STRÅLERØR	FIRE HOSE WITH NOZZLE	2
	GASSBEHÅLDER FOR STASJUMART SLIKKEANLEGG	FIXED FIRE-EXTINGUISHING BATTERY gas	1
	BERBER CO2 -BRANNSLUCKER 6kg, CO2	FIRE EXTINGUISHER 6kg, CO2	1
	BERBER SKUM -BRANNSLUCKER 9l	FIRE EXTINGUISHER 9l, FOAM	3
	BERBER PULVER -BRANNSLUCKER 12kg, PULVER	FIRE EXTINGUISHER 12kg, POWDER	1
	DIMRADE BESKYTTET MED STASJUMART SLIKKEANLEGG MED GASS	SPACE PROTECTED BY GAS FIRE-EXTINGUISHING	1
	NODGENERATOR	EMERGENCY SOURCE OF ELECTRICAL POWER (BATTERY)	1
	NODBATTERI	EMERGENCY SOURCE OF ELECTRICAL POWER (BATTERY)	1
	NODKORINGSSTAVLE	EMERGENCY SWITCH BOARD	1
	PRIMÆR FLUKTRETNING	PRIMARY MEANS OF ESCAPE	1
	SEKUNDÆR FLUKTRETNING	SECONDARY MEANS OF ESCAPE	1
	OPPLASBAR FLATE 10 mm	LIFEBRAT 10 mm	2
	LIVBØYE MED LINE	LIFEBUOY WITH LINE	1
	LIVBØYE MED LYS	LIFEBUOY WITH LIGHT	1
	LIVBØYE MED LYS OG RØYK	LIFEBUOY WITH LIGHT AND SMOKE	1
	RENNINGSVEST	LIFEJACKET	15
	SAKT	RADAR TRANSPONDER	1
	6 HANDBLUSS OG 6 FALLSKJERM LYS	6 HANDFLARES AND 6 PARACHUTE LIGHTS	1
	LINEKASTER	LINE THROWING APPLIANCE	1
	BERBER VHF NØDKOMMUNIKASJONSSETT	PORTABLE RADIO	2
	EP1R8	EP1R8	1
	DYRELEVELSESBØKTER	IMMERSION SUIT	10
	RENNINGSBØRE	STRETCHER	1
	MEDISINKISTE	MEDICAL LOCKER	1

N SUNDIN
DOCKSTAVARVET AB
S-870 33 DOCKSTA SWEDEN

Lot:
LPP: 16,8 m
B max: 5,2 m
Drauf: 52 m
Displ: Bl. of DWL: 105 m
volume of DWL: 27,62 h
Built: 2008

LOS 116/3YAE
SÄKERHETSPLAN
Date: 2012/01 Rev:2 Sign: JET Skala: 1:100